
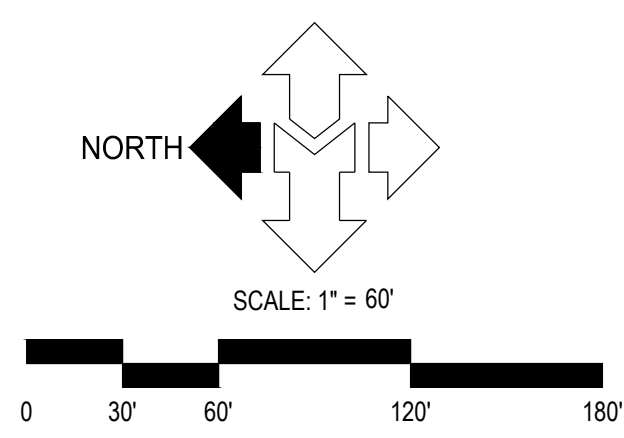


S:\2017\mes\17512\Civil\Prod\04\17512 Concept Overlaid.dwg, Jul 15, 2021 - 11:55am

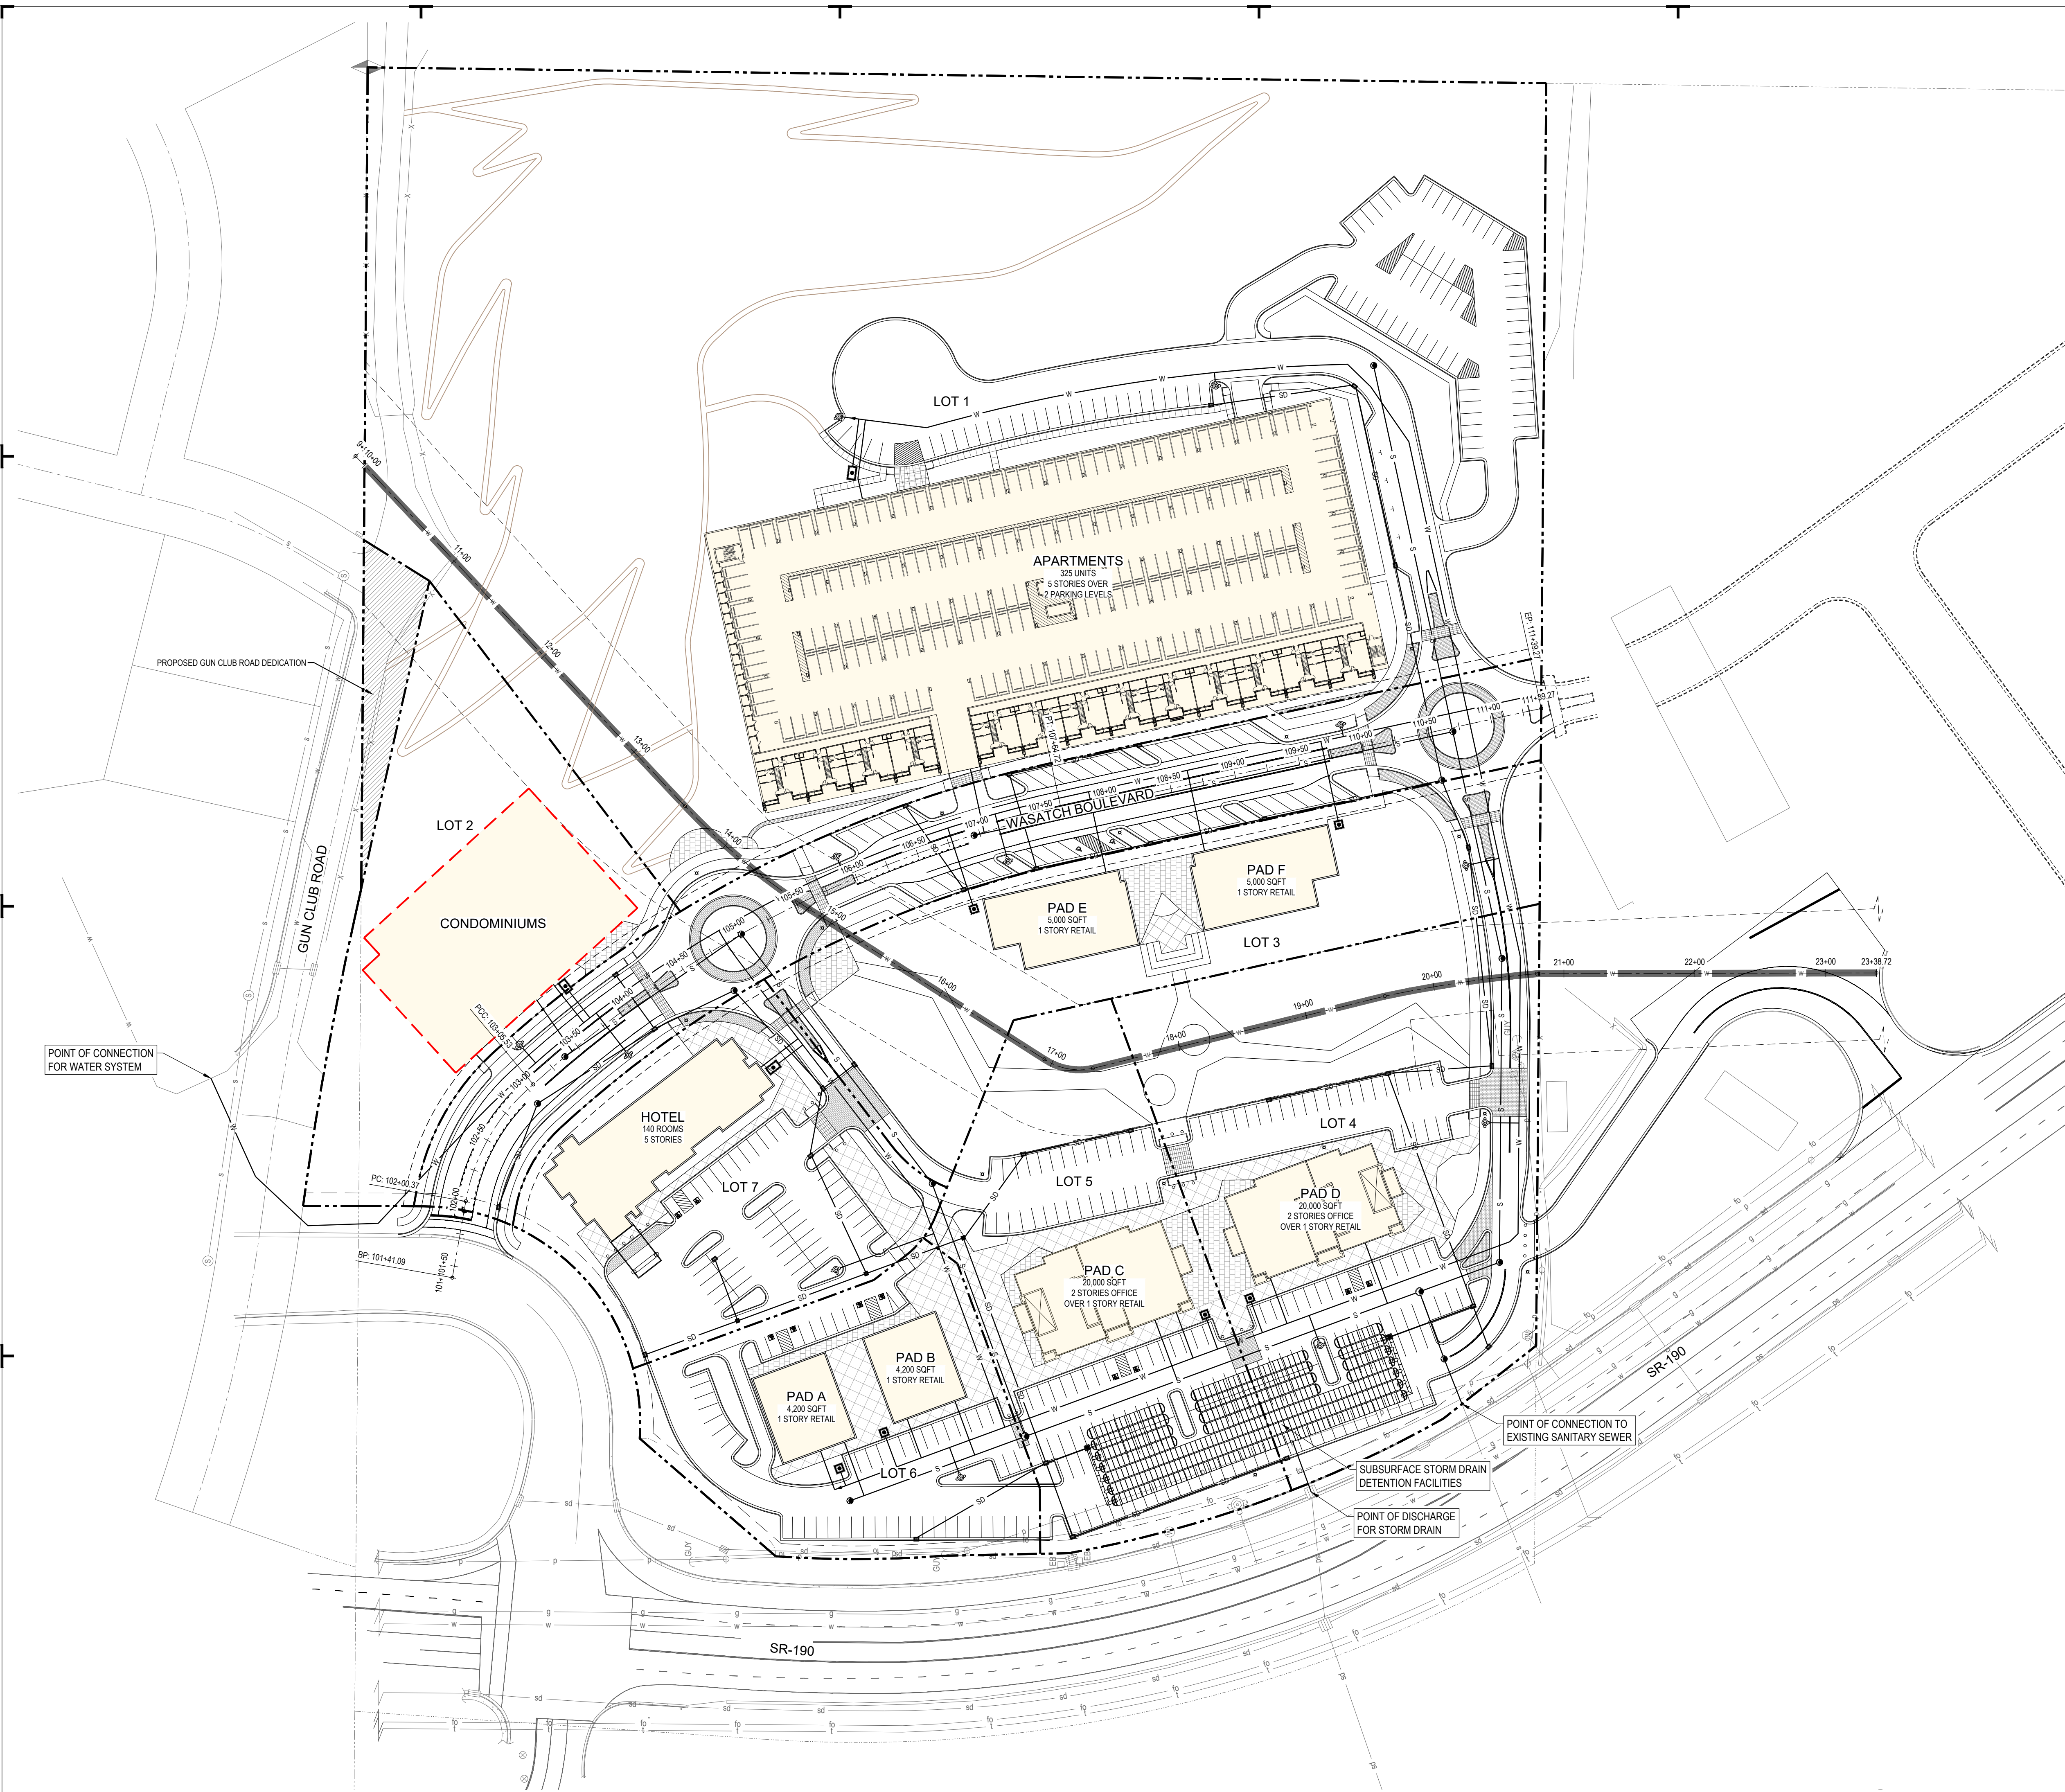

UTILITY LEGEND

NEW	EXISTING	
X	X	FENCE LINE
atms	atms	ATMS CABLE
tv	tv	CABLE TV LINE
c	c	COMMUNICATIONS LINE
fo	fo	FIBER-OPTIC CABLE
f	f	FIRE LINE
irr	irr	IRRIGATION LINE
g	g	NATURAL GAS LINE
ohc	ohc	OVERHEAD COMMUNICATIONS
ohp	ohp	OVERHEAD POWER LINE
oht	oht	OVERHEAD TELEPHONE LINE
ohv	ohv	OVERHEAD TELEVISION LINE
p	p	POWER LINE
pic	pic	POWER/COMMUNICATIONS LINE
pit	pit	POWER/TELEPHONE LINE
ptc	ptc	POWER/TELECOMM LINE
rd	rd	ROOF DRAIN LINE
sw	sw	SECONDARY WATER LINE
s	s	SANITARY SEWER LINE
st	st	STEAM LINE
sd	sd	STORM DRAIN LINE
t	t	TELEPHONE LINE
tic	tic	TELEPHONE/COMM LINE
ud	ud	UNDERDRAIN
ugc	ugc	UNDERGROUND COMMUNICATIONS
ugp	ugp	UNDERGROUND POWER LINE
ugt	ugt	UNDERGROUND TELEPHONE LINE
ugtv	ugtv	UNDERGROUND TELEVISION
w	w	WATER LINE
⊕	⊕	POWER POLE
⊕	⊕	UTILITY POLE
⊕	⊕	GUY ANCHOR
⊕	⊕	POWER TRANSFORMER
⊕	⊕	TRAFFIC SIGNAL CABINET
⊕	⊕	LIGHT POLE
⊕	⊕	TELEPHONE RISER
⊕	⊕	TELEPHONE MANHOLE
⊕	⊕	TRAFFIC SIGNAL BOX
⊕	⊕	WATER MANHOLE
⊕	⊕	WATER VALVE
⊕	⊕	WATER METER
⊕	⊕	FIRE HYDRANT
⊕	⊕	SANITARY SEWER MANHOLE
⊕	⊕	SANITARY SEWER CLEANOUT
⊕	⊕	STORM DRAIN MANHOLE
⊕	⊕	STORM DRAIN CURB INLET
⊕	⊕	STORM DRAIN CATCH BASIN
⊕	⊕	STORM DRAIN CLEANOUT
⊕	⊕	STORM DRAIN COMBO BOX

THE MASSING AND DENSITY OF THE CONDOMINIUMS, INCLUDING TOTAL NUMBER OF UNITS, HEIGHT, SQUARE FOOTAGE, ETC. WILL BE DETERMINED WITH A FUTURE PHASE.

AVOID CUTTING UNDERGROUND UTILITIES. IT'S COSTLY.

Call Before You Dig

1-800-662-4111

NOTICE!

THE CONTRACTOR SHALL BE RESPONSIBLE FOR THE LOCATION, PROTECTION, AND RESTORATION OF ALL BURIED OR ABOVE GROUND UTILITIES, SHOWN OR NOT SHOWN ON THE PLANS.

McNEIL ENGINEERING
 Economic and Sustainable Design, Professionals You Know and Trust
 8610 South Sandy Parkway, Suite 200 Sandy, Utah 84070 801.255.7700 mcneilengineering.com
 Civil Engineering • Consulting & Landscape Architecture
 Structural Engineering • Land Surveying & I&DS

WASATCH ROCK
 6695 WASATCH BLVD
 COTTONWOOD HEIGHTS, UT

REVISIONS

REV	DATE	DESCRIPTION

PROJECT NO: 17512
 DRAWN BY: JHF, DSM
 CHECKED BY: TJD
 DATE: JULY 14, 2021

UTILITY PLAN
 PHASE 1
UP-1